


Floor Plan/ Equipment Layout


Scale: 1/8"=1'

- Notes:
1. Gas demand in BTU as provided by Owner
 2. Pipe size determined with reference to 2016 CBC Table 2116.2(1) with the following specs:
Gas: Natural
Inlet pressure: less than 2psi
Pressure drop: 0.5 in w.c.
Specific gravity: 0.6
 3. BTU = 1100 cubic foot per hour
 4. All pipe sizes are minimum. Larger sizes may be used at the owner's discretion

Tenant Improvement
Project Address:
12923 South
Budlong Ave
Gardena, CA 90247
Owner:
Hallab Pastry 1881

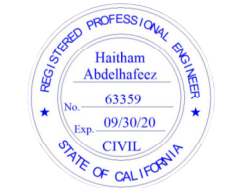

Haitham A. Hafeez

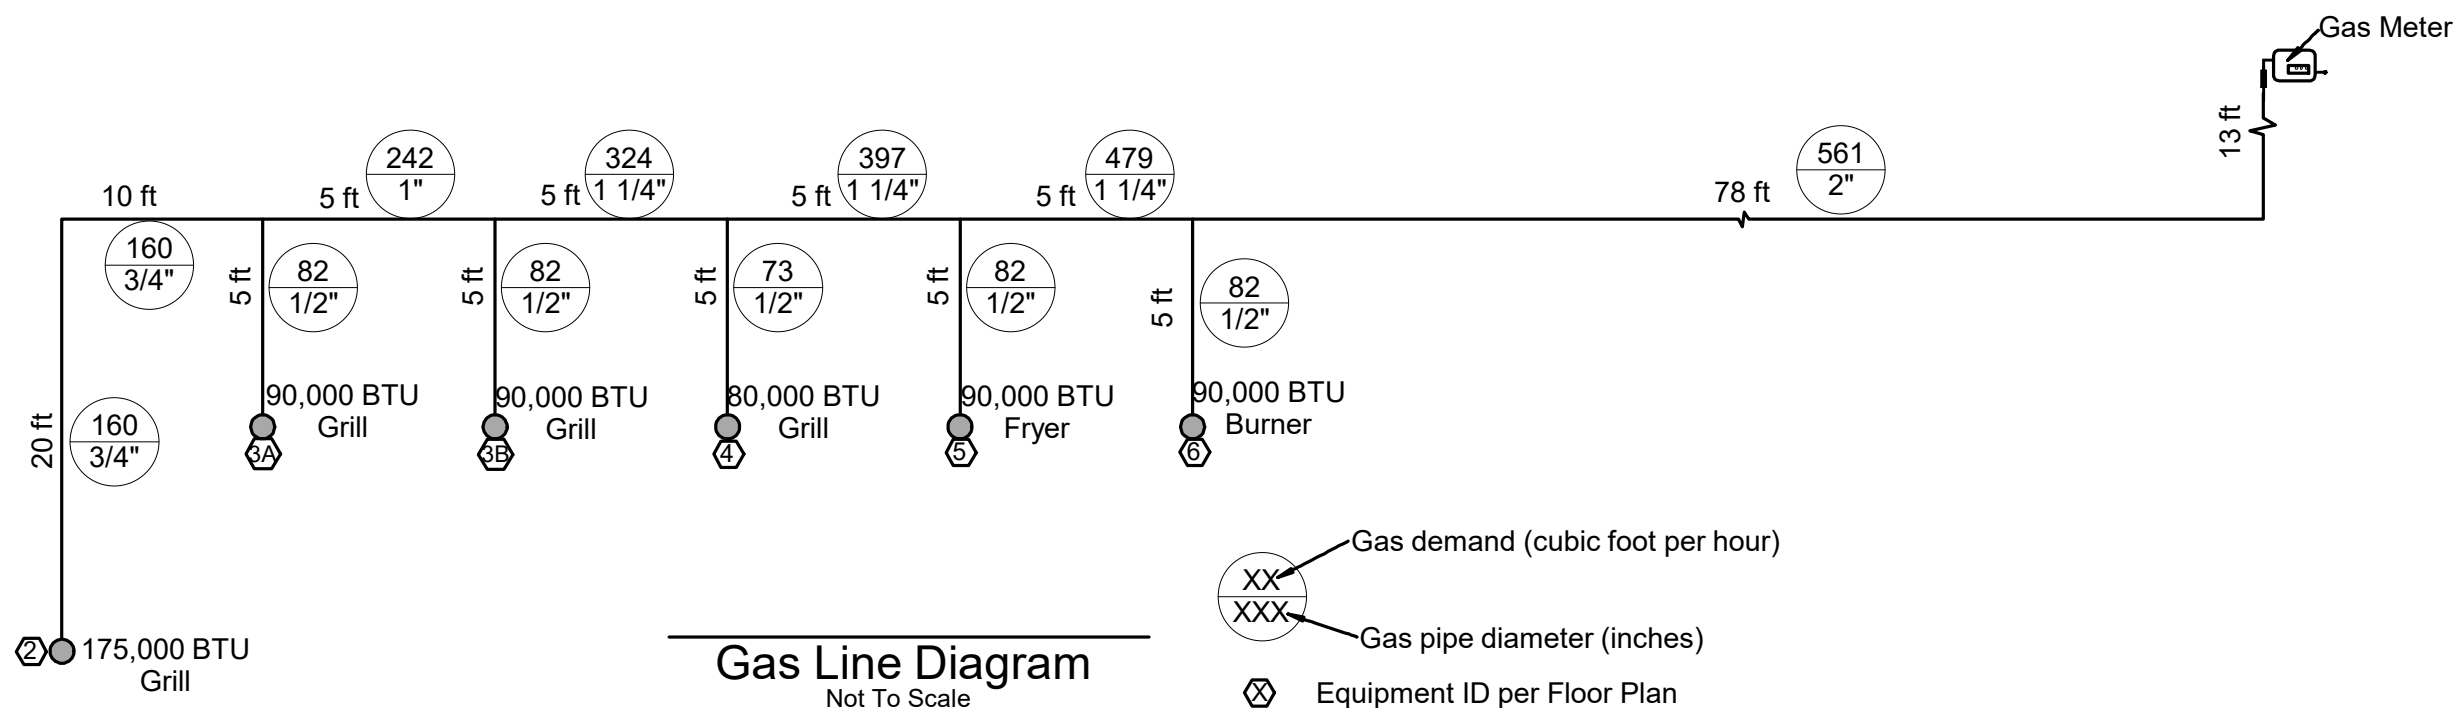

Gas Line Diagram
Not To Scale

www.Handasainc.com
421 N Brookhust St Suite 222
Anaheim, CA 92801
Project Engineer:
Haitham A. Hafeez, P.E.
Tel (657) 230 - 9228
Fax (714) 917 - 2977
info@handasainc.com

Revisions	
△	
△	
△	
△	
△	

Scale: 1/4" = 1' UNO
Original Date: 02/06/2019
Sheet No.